

ADDENDUM 01 - COVER SHEET



LEE COUNTY GOVERNMENT **NORTH CAROLINA**

COKE BUILDING / WAREHOUSE FIRE SPRINKLER SYSTEM

PROJECT #4850-02-26

ADDENDUM 01 ISSUED: 07/07/2026

ADDENDUM 01

LEE COUNTY PROJECT #4850-02-26 COKE BUILDING / WAREHOUSE FIRE SPRINKLER SYSTEM

GENERAL:

Bidders are requested to insert this Addendum in the front of the project bid documents. Inform all concerned that the Bidding Documents are modified by this Addendum.

The following modifications and clarifications are hereby made a part of the Bidding Documents and supersede or otherwise modify the provisions of the published project bid documents date July 7, 2026 – Addendum No. 01.

QUESTIONS:

1. Warehouse Ceiling Height?

ANSWER: 21'4" from concrete floor to bottom of metal roof decking

2. Mezzanine Drawing?

ANSWER: See attached drawing (A-3 Mezzanine Floor Plan) for mezzanine level

3. Hydrant Static & Residual Flow Testing?

ANSWER: See attached Flow Test from 9/17/25

4. Last Day to Submit Questions?

ANSWER: July 9, 2026









5. Final Addendum Issue Date?

ANSWER: July 10, 2026

END OF ADDENDUM NO 01

919-718-4605 Ext. 5495


bkey@leecountync.gov

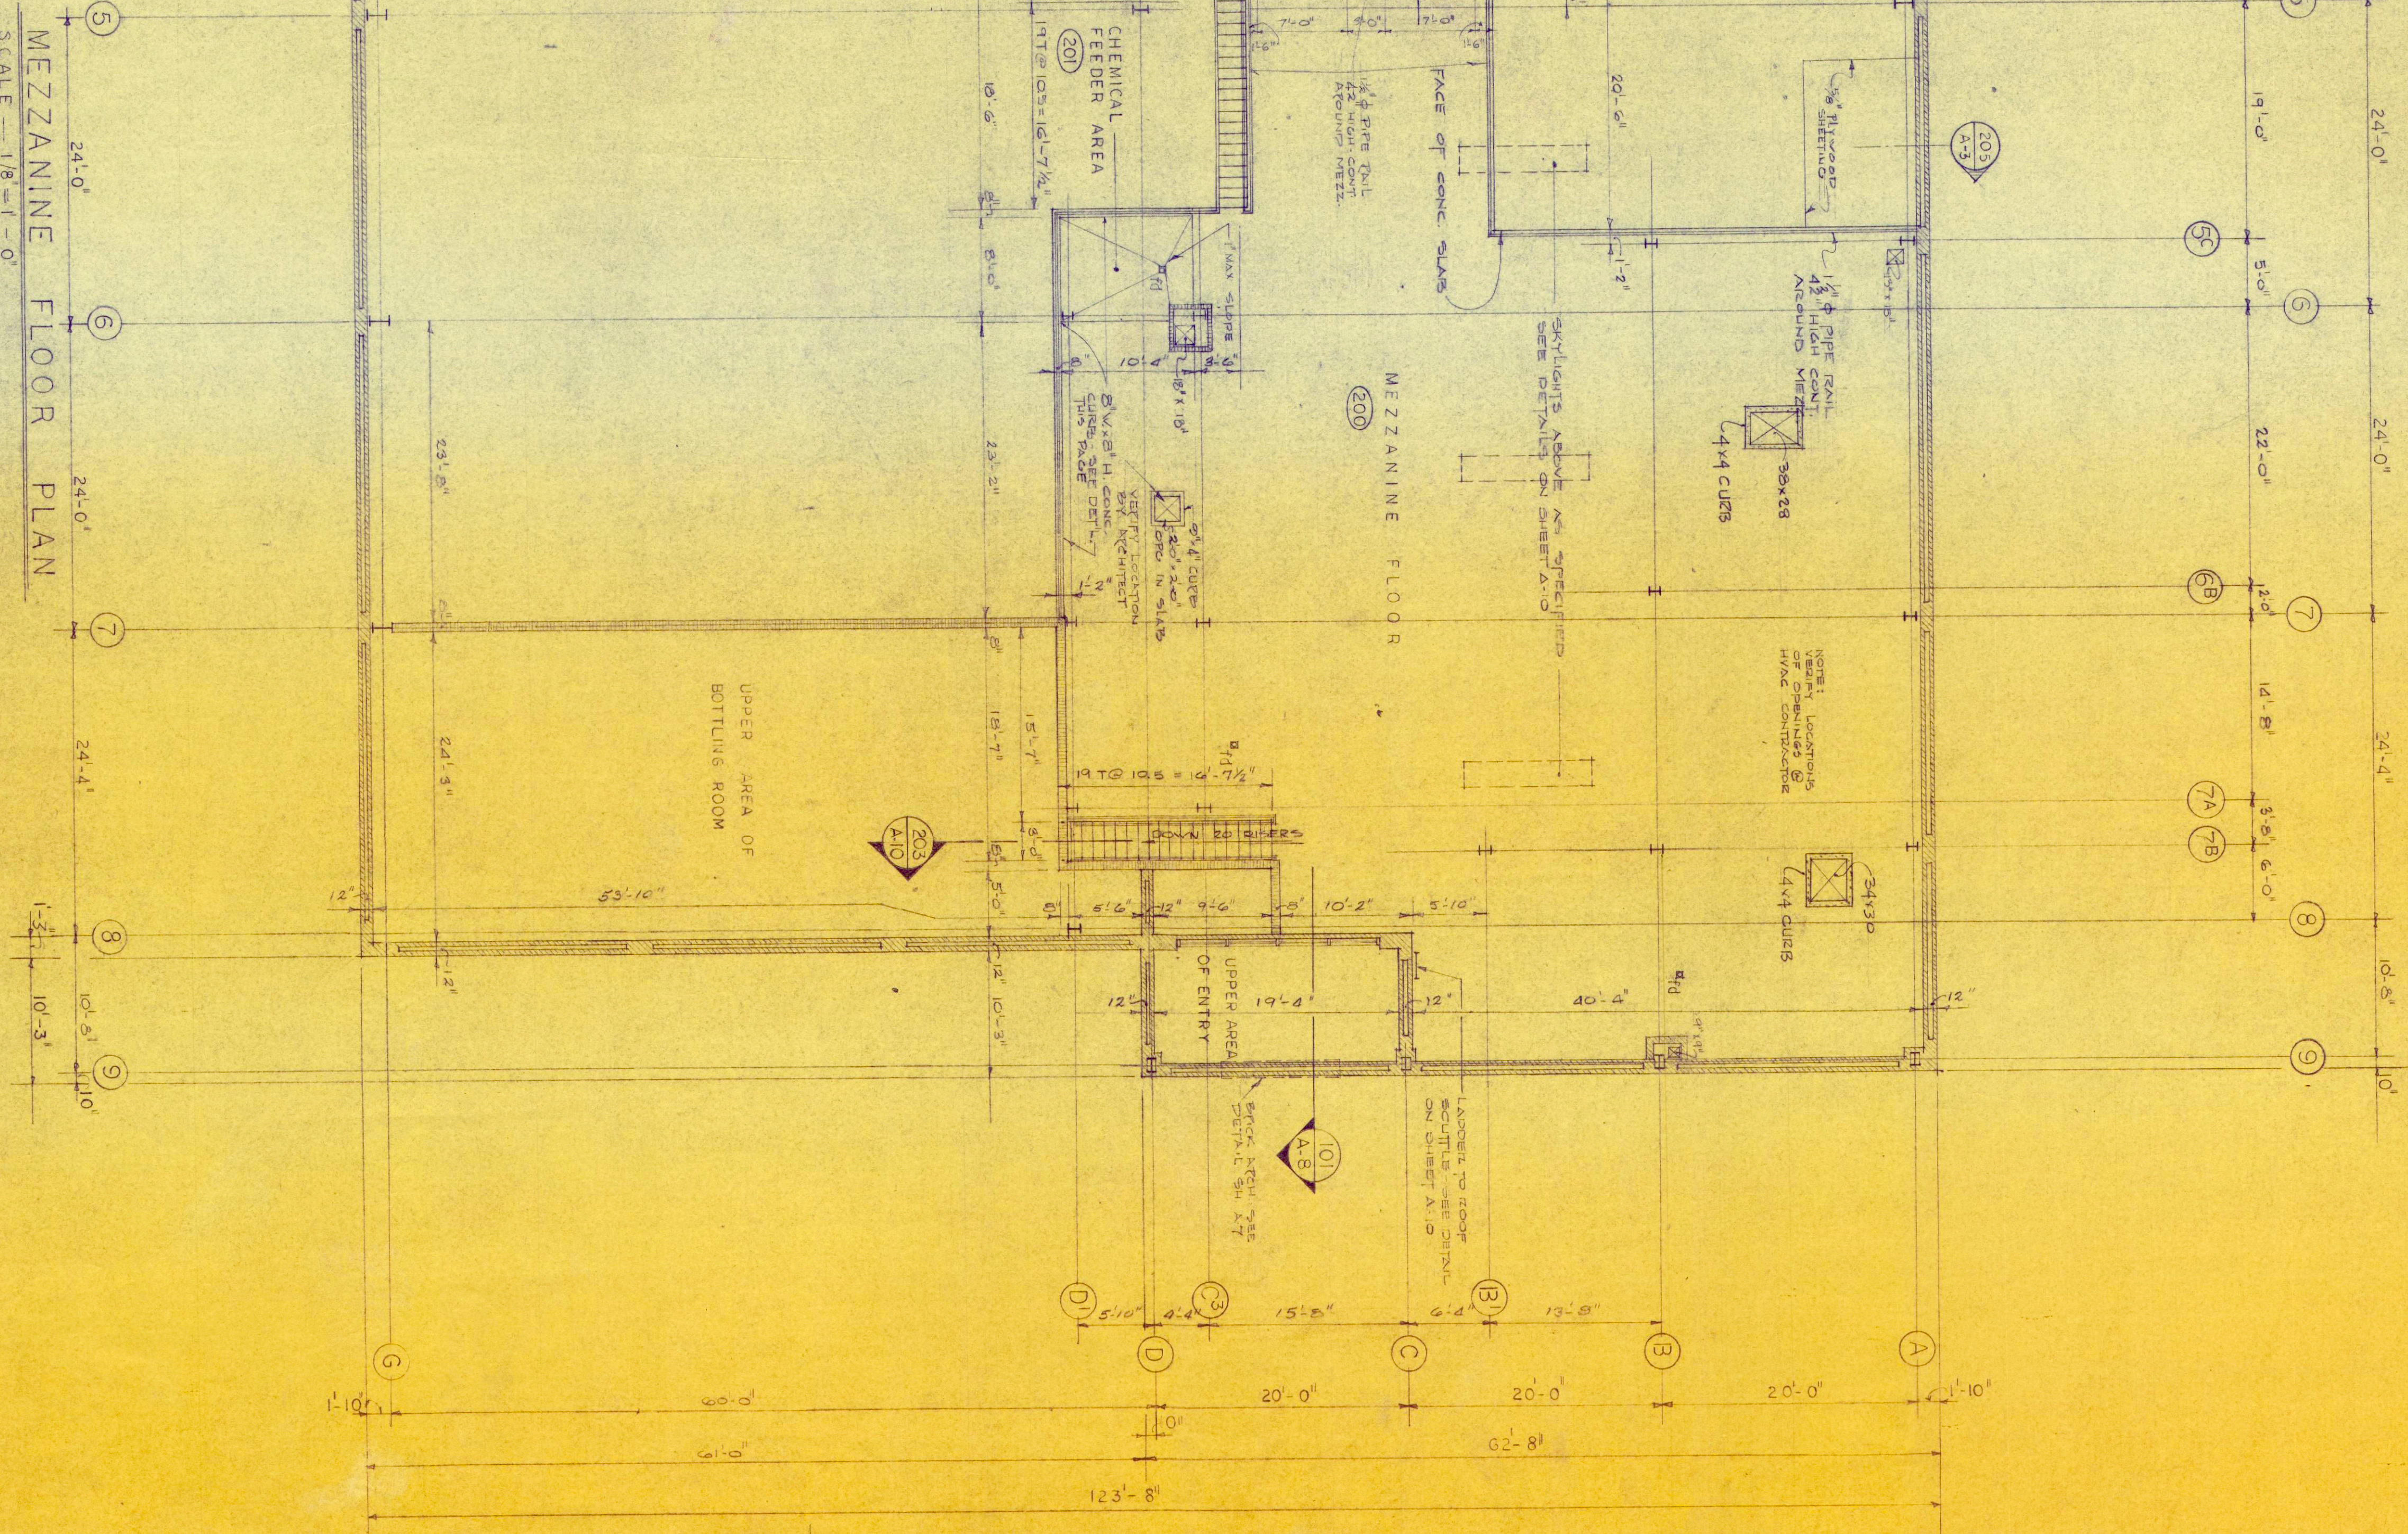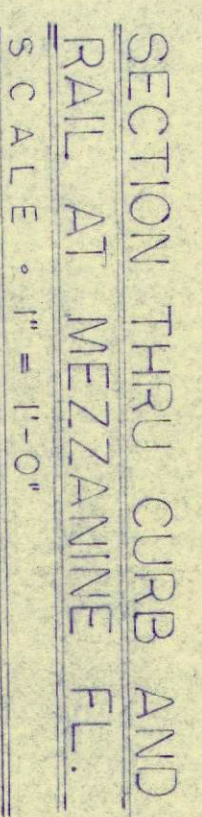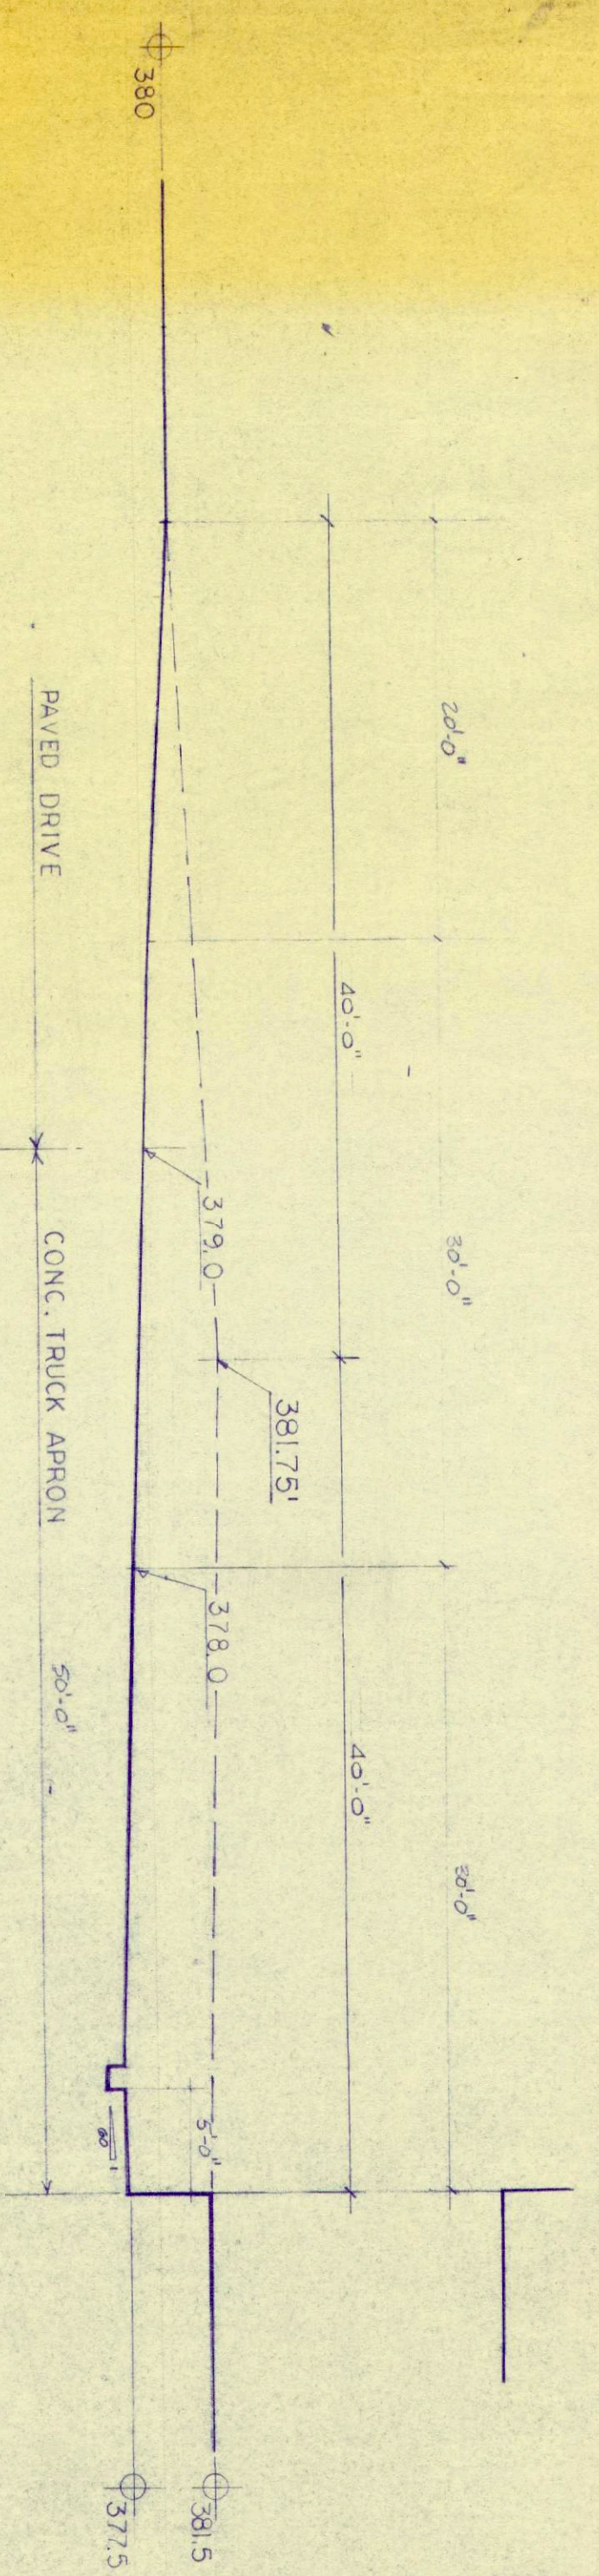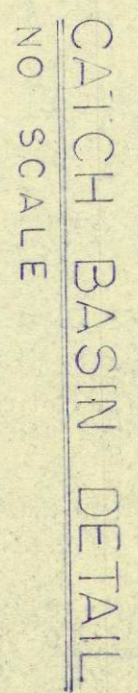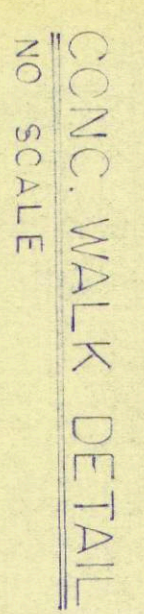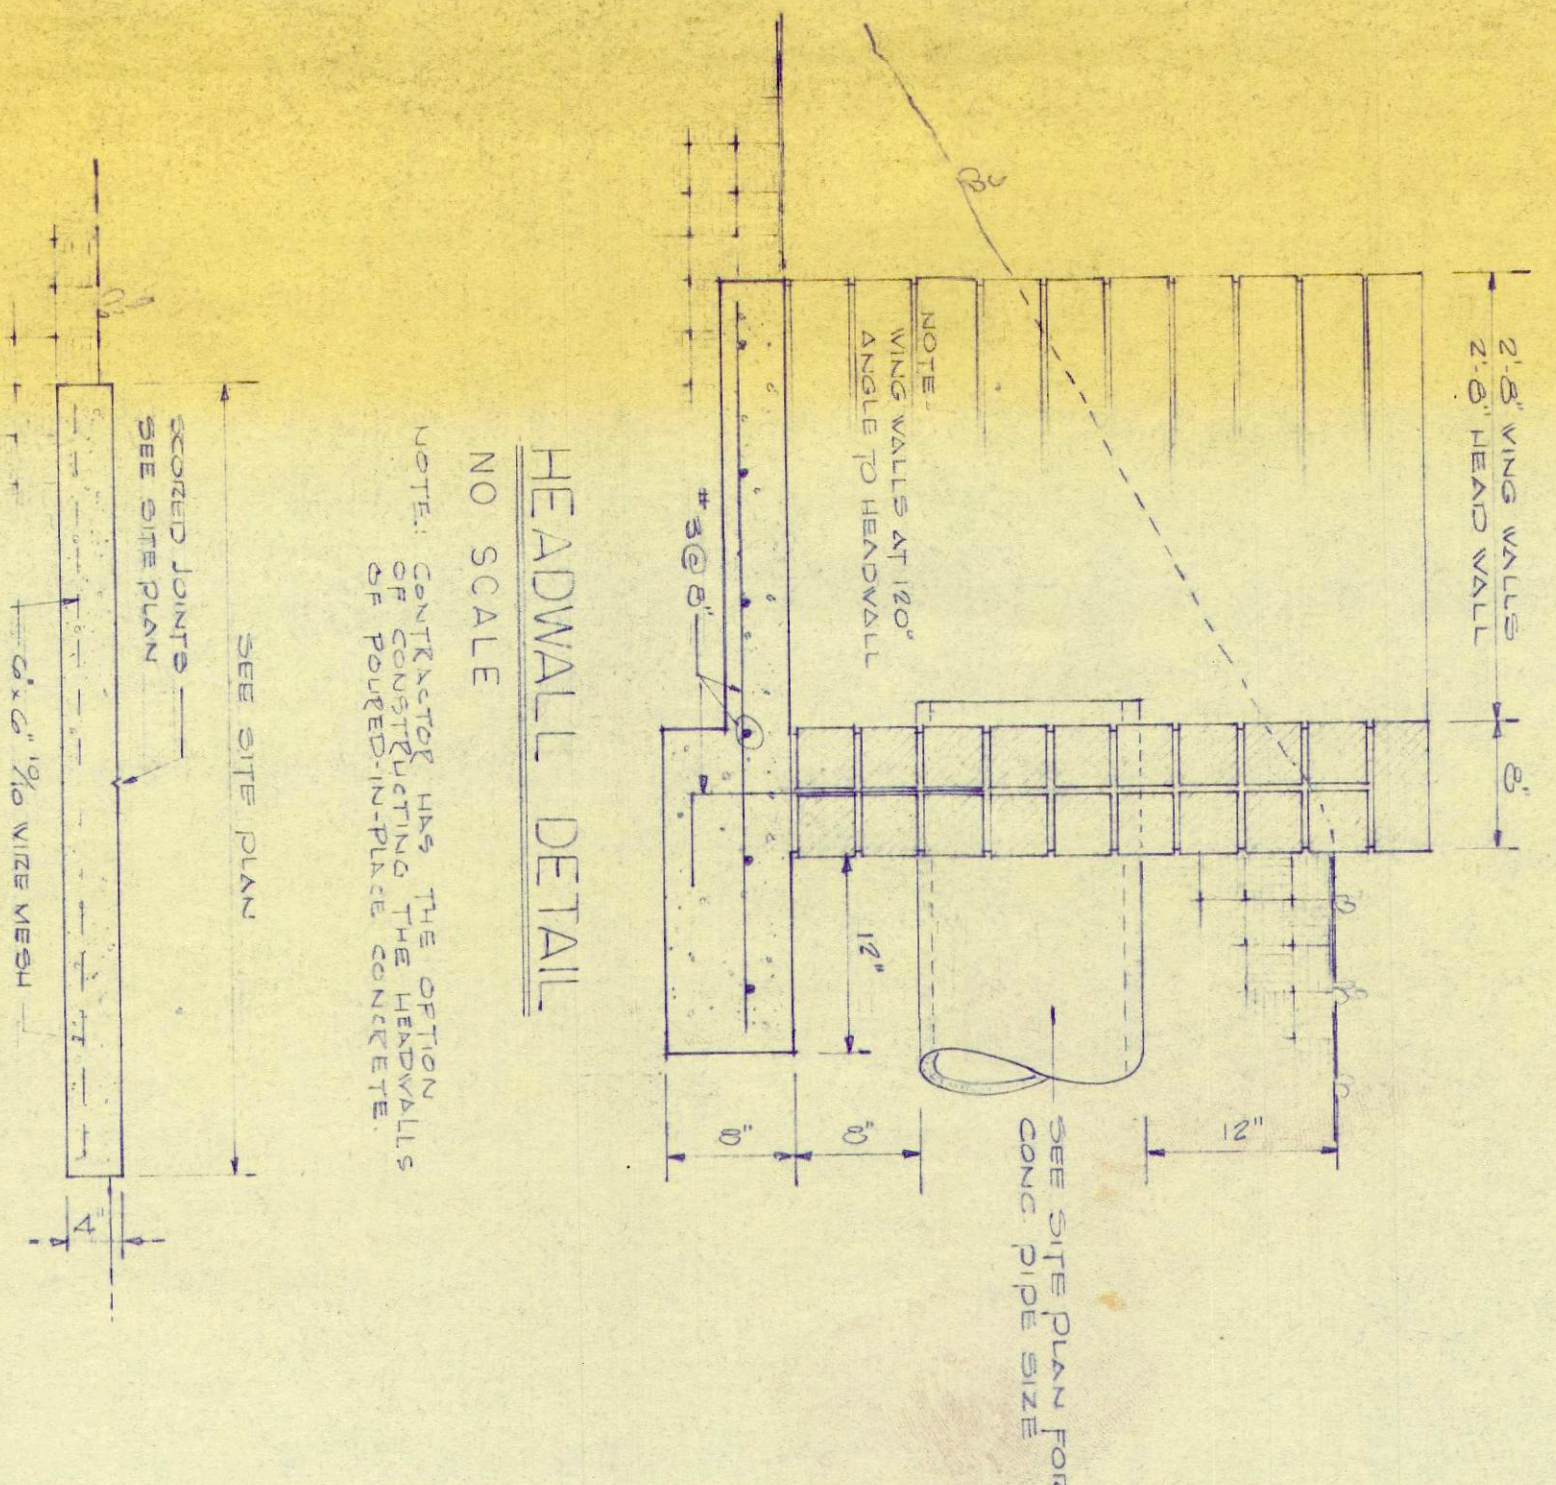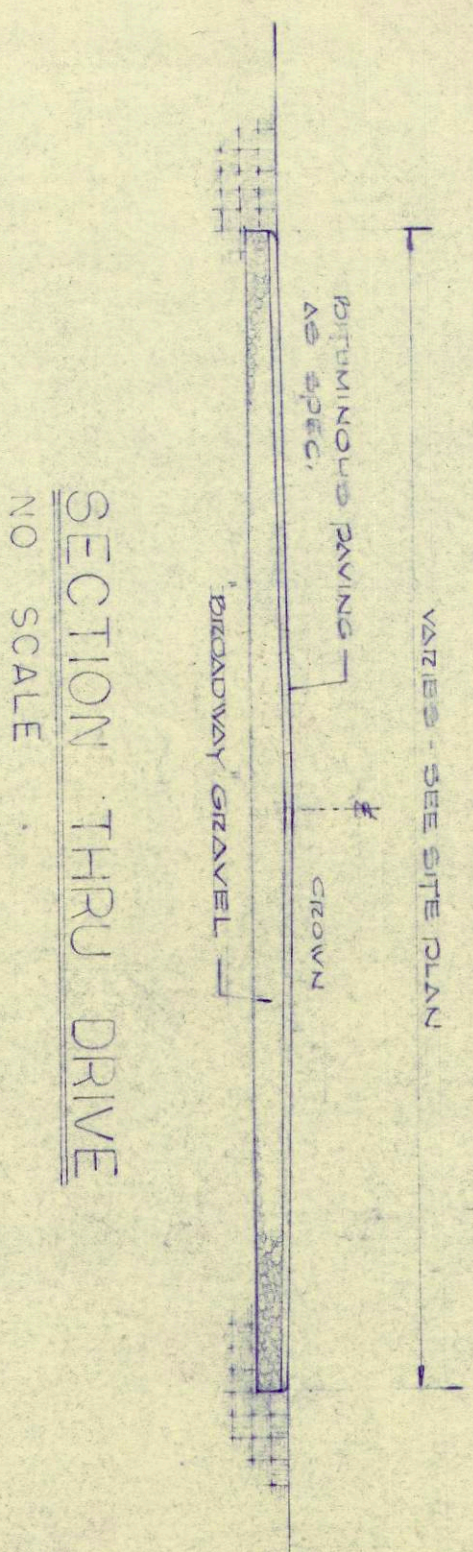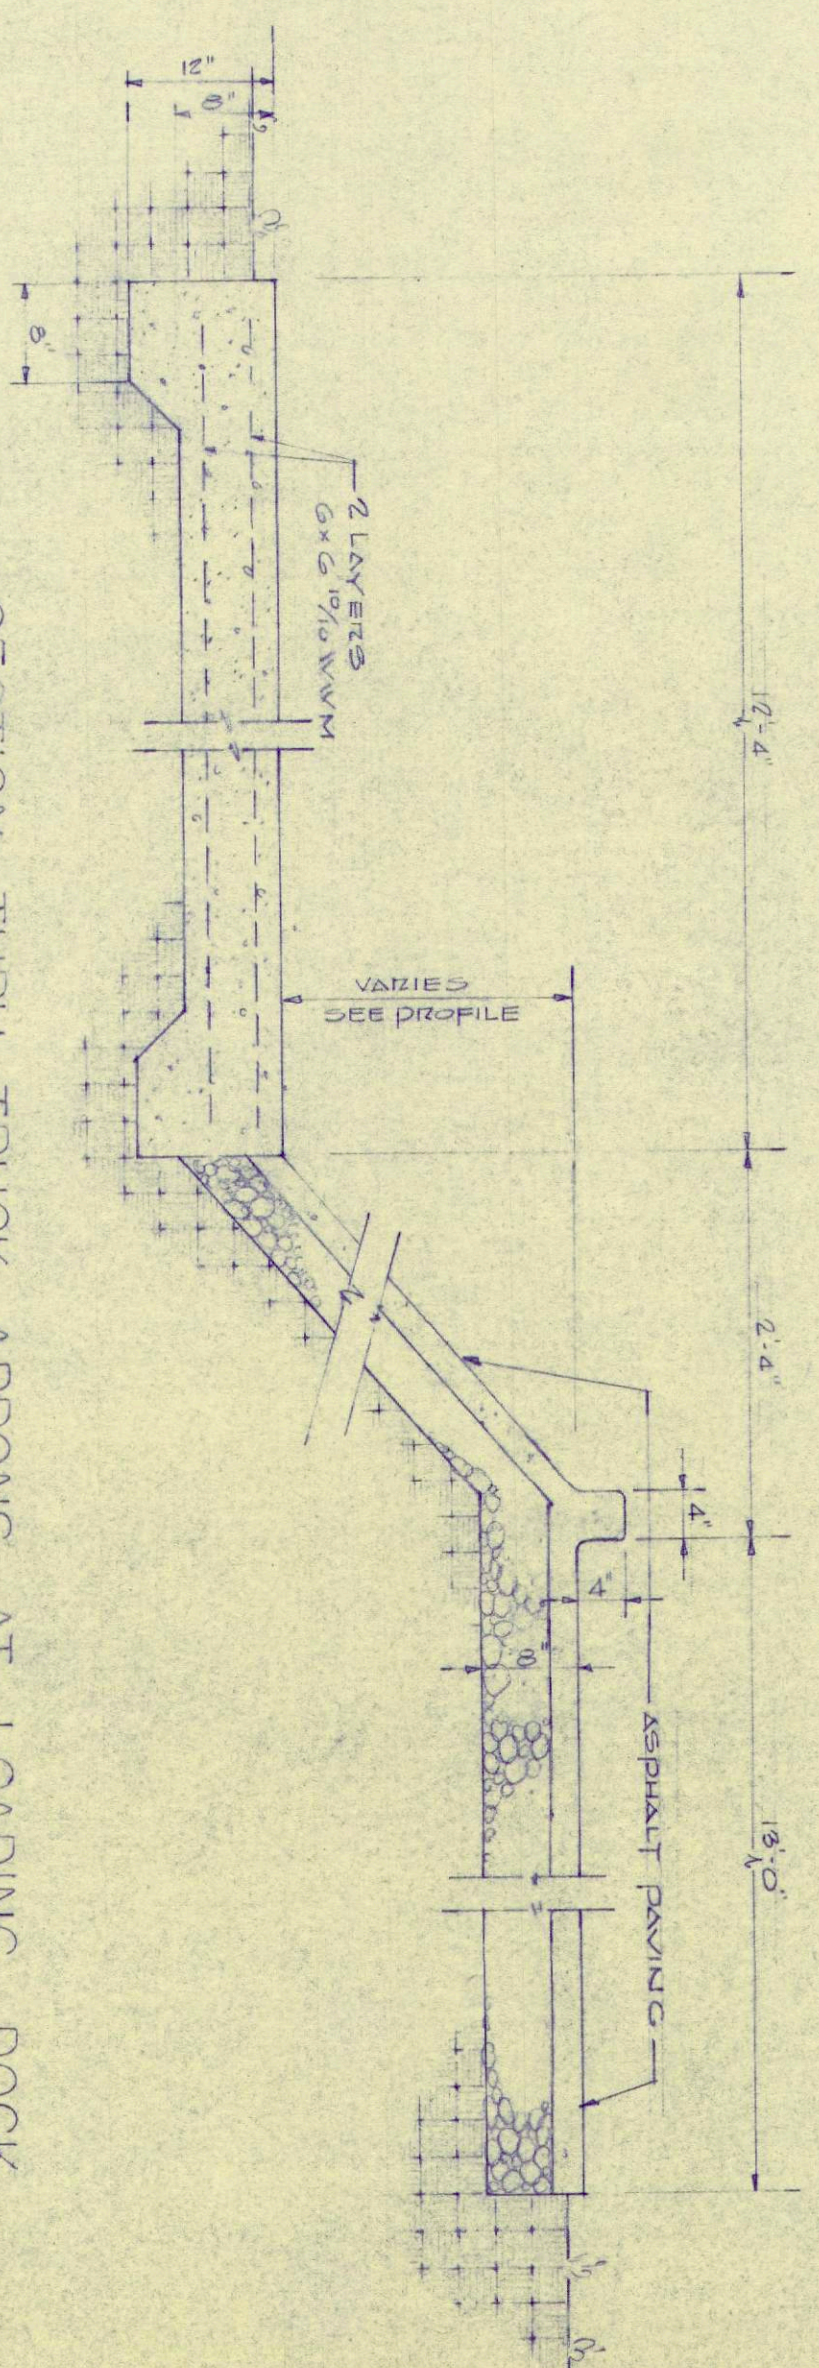

GENERAL NOTES:
1. THESE DRAWINGS ARE INSTRUMENTS OF SERVICE AND AS SUCH ARE THE PROPERTY OF THE ARCHITECT. UPON COMPLETION OF THE WORK ALL DRAWINGS EXCEPT THE CONTRACT COMES ARE TO BE RETURNED TO THE ARCHITECT.

REVISIONS:
(1) REVISION PER CONTRACT AMOUNT

DATE:
4-20-69

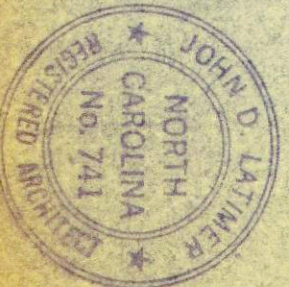

JOHN D. LATIMER & ASSOCIATES
ARCHITECTS
BOX 177, DURHAM, NORTH CAROLINA

DRAWN BY: D.C. LAM
CHECKED BY: W.C.
APPROVED BY: W.C.
DATE: APRIL 4, 1969

MEZZANINE FLOOR PLAN
SCALE: AS NOTED
SANFORD, *Coca-Cola* BOTTLING COMPANY
SANFORD, NORTH CAROLINA

JOB NO. 1069
SHEET NO. A-3
OF A-10



HYDRANT STATIC & RESIDUAL

REQUESTOR: Matt Buchann

Date: 9/17/25

STATIC

LOCATION/ADDRESS 1615 Hawkins Ave

HYDRANT ID# HWKN-200

STATIC PSI 60

RESIDUAL PSI 55

FLOW

LOCATION/ADDRESS 1751 Hawkins Ave

HYDRANT ID# HWKN-209

FLOW PSI 45

FLOW GPM 1244

NOTES:
